


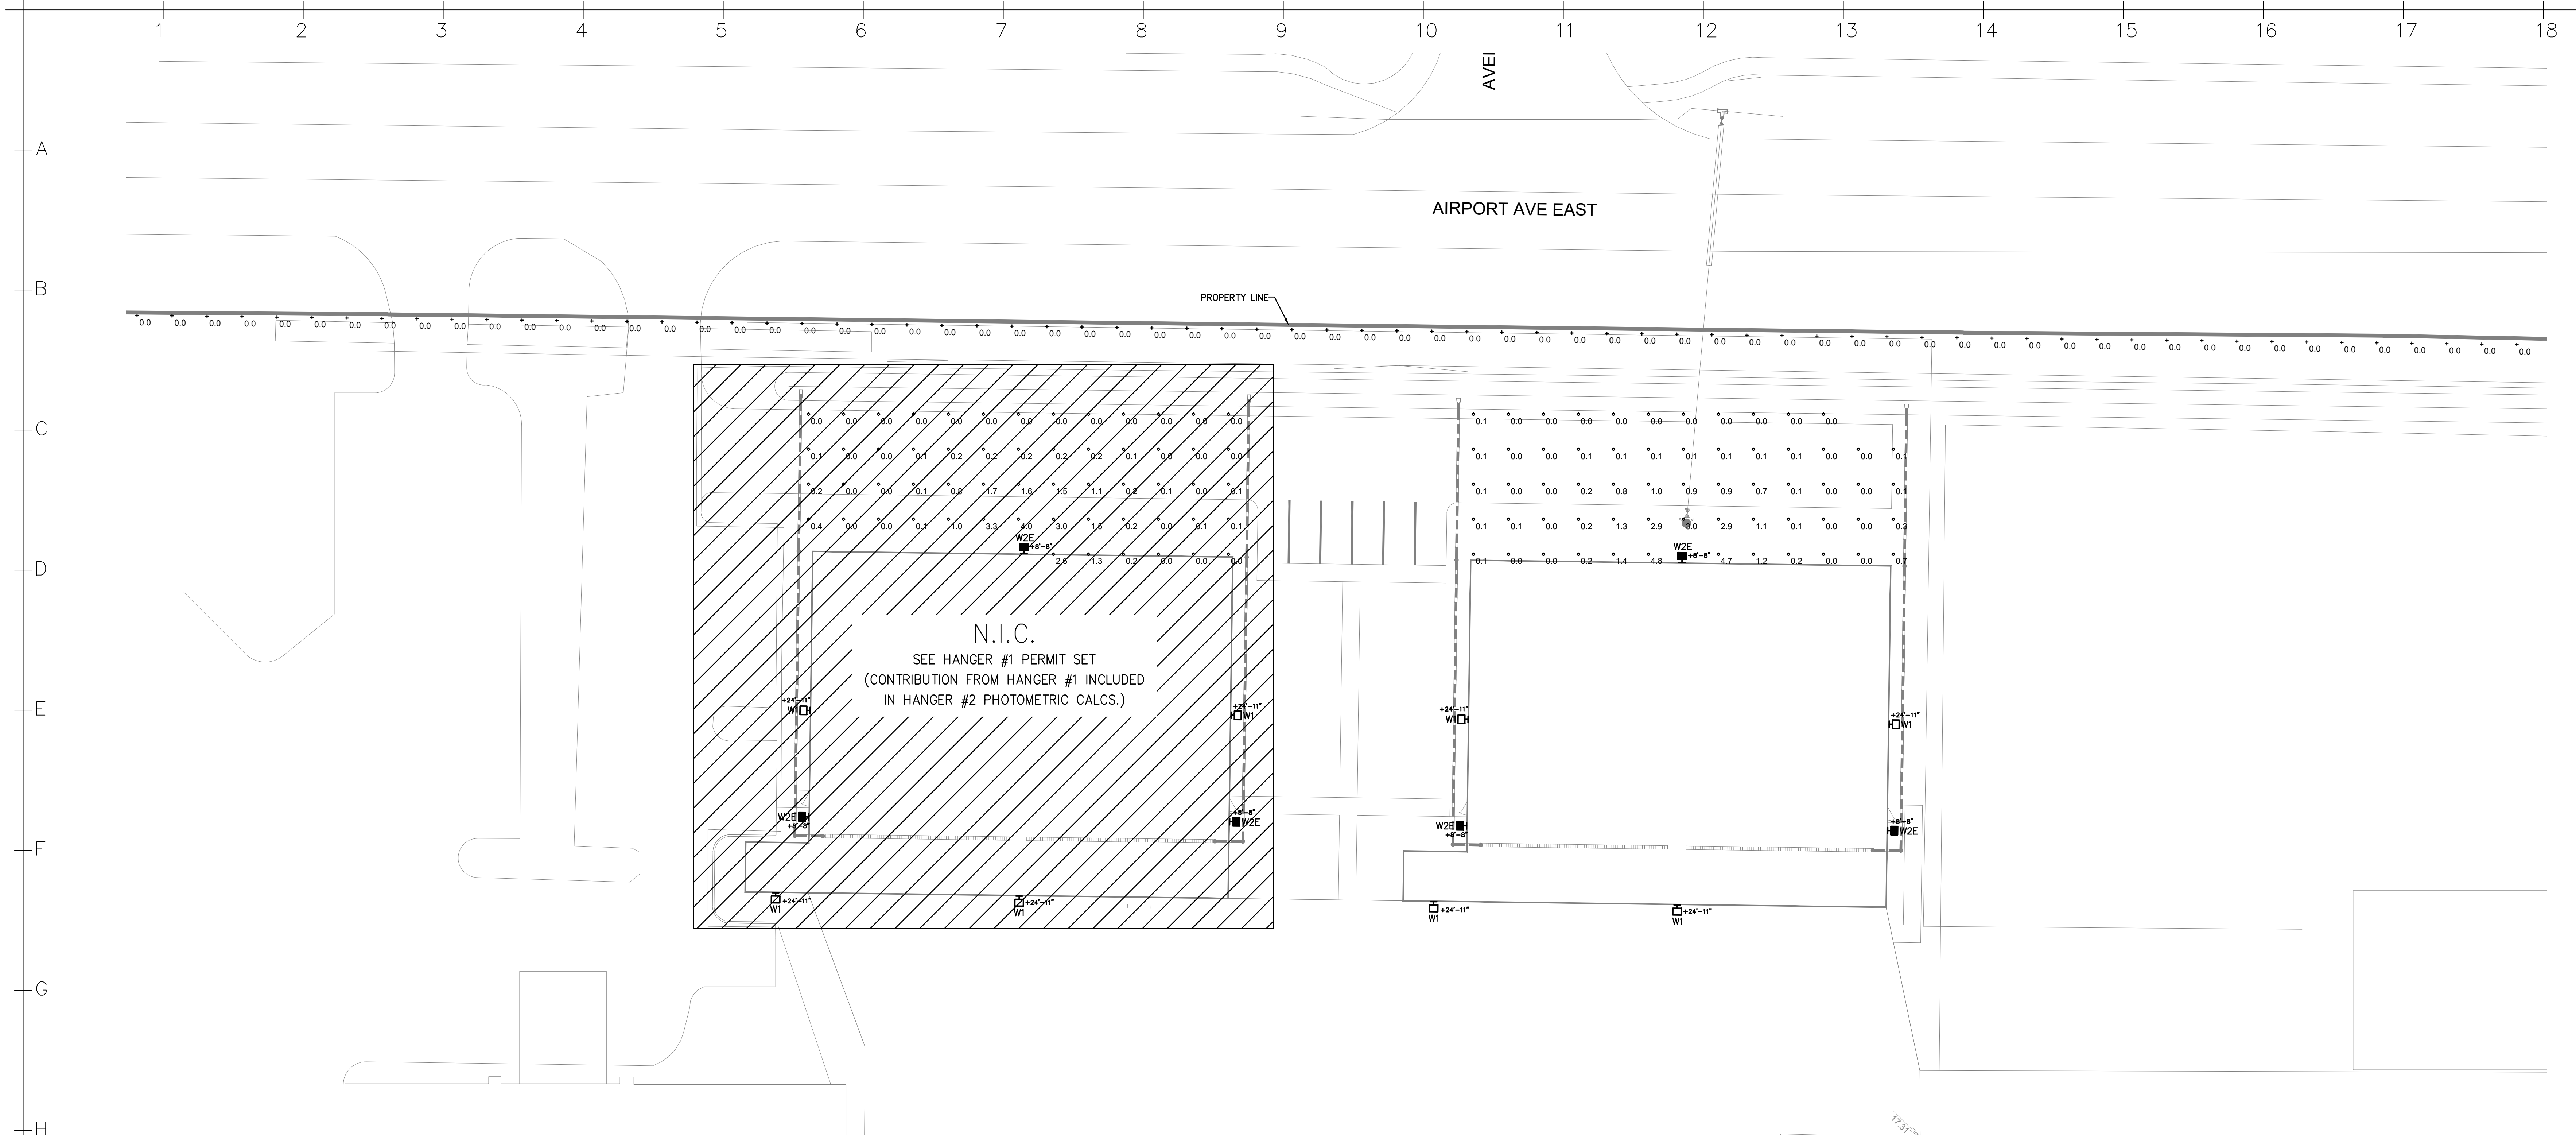


PROJECT TITLE
VENICE AIRCRAFT
HANGAR 2
VENICE MUNICIPAL AIRPORT
150 AIRPORT AVE E
VENICE, FLORIDA 34285

DRAWING ISSUE LOG

PERMIT SET 12/13/24

REVISION 1 02/24/25

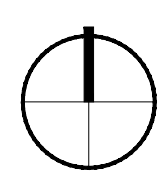

1 PHOTOMETRIC SITE PLAN
SCALE: 1" = 20'-0"


Schedule							
Symbol	Type	QTY	Manufacturer	Catalog	Description	Number Lamps	Lamp Output
W1	W1	8	EXO	RWL2-160L-80-4K7-4-U	SEE FIXTURE CUT SHEET ON THIS SHEET.	1	11125
W2E	W2E	6	EXO	RWL1-48L-25-4K7-4W-U	SEE FIXTURE CUT SHEET ON THIS SHEET.	1	3680

Statistics						
Description	Symbol	Avg	Max	Min	Max/Min	Avg/Min
Property Line	+	0.0 fc	0.0 fc	0.0 fc	N/A	N/A
General Lighting	◇	0.5 fc	4.8 fc	0.0 fc	N/A	N/A

GENERAL NOTES

- AIRPORT HANGER HAS 24/7 ACCESS.

24110
Harold Hart & Associates, Inc.
CONSULTING ENGINEERS
6928 W. LINEBAUGH AVE. • STE. 101 • TAMPA, FL 33625
Telephone: (813) 287-2719 • Fax: (813) 961-1585
COA #4221 PE #70912

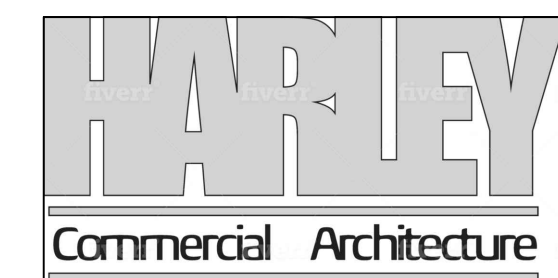

411 APOLLO BEACH BLVD, SUITE 200
APOLLO BEACH, FLORIDA 33572
813-760-1957
JRH@HARLEYCOMM.COM

PROJECT NUMBER: 24110

DRAWN BY: JCK

CHECKED BY: CK

COPYRIGHT: HARLEY COMMERCIAL ARCHITECTURE

PS100



RATIO Wall

RWL1/RWL2 LED WALLPACK

FEATURES

- Low profile LED wall luminaire with a variety of ES distributions for lighting applications such as retail, commercial and industrial building mount
- Featuring Strike and Micro Strike Optics which maximizes target zone illumination with minimal losses at the house side, reducing light trespass issues
- Visual comfort standard
- Control options including photo control, occupancy sensing, NK Distributed IntelligenceSM, LightGRDSM and 7-pin with networked controls
- Battery Backup options available for emergency code compliance
- Quick-mount adapter allows easy installation/maintenance
- 347V and 480V versions for industrial applications and Canada



CONTROL TECHNOLOGY

LIGHTGRDSM

SERVICE PROGRAM

QS10

SPECIFICATIONS

CONSTRUCTION

- Die-cast housing with hidden vertical heat fins that are optimal for heat dissipation while keeping a clean smooth outer surface
- Corrosion resistant, die-cast aluminum housing with powder coat paint finish
- Powder paint finish provides durability in outdoor environments. Tested to meet 1000 hour salt spray rating
- Optics - Strike optical aperture illuminates to create a larger luminous surface area resulting in a low glare appearance without sacrificing optical performance
- 48 or 160 mid-power LEDs
- 3000K, 4000K or 5000K (70 CRI/80 CRI) CCT
- Zero uplight distributions
- LED optics provide ES type II, III and IV distributions. Type II only available in RWL2 configurations

INSTALLATION

- Quick-mount adapter provides easy installation to wall or to recessed junction boxes (4" square junction box)
- Designed for direct (J) box mount
- Integral back box contains 12" conduit huls
- Integral backbox provided as standard with selection of some options
- Electrical - 120V-277V universal voltage 50/60Hz 0-10V dimming drivers
- 347V and 480V dimmable driver option for all wattages above 35W
- Ambient operating temperature -40°C to 40°C
- Driver RoHS and IP66



currentlighting.com/beacon
© 2025 Current Lighting Solutions, LLC. All rights reserved. Information and specifications subject to change without notice. All values are design (D) typical values unless otherwise indicated or otherwise specified.

Page 1 of 10
Ratio_Wall_Spec_Sheet_R1



RATIO Wall

RWL1/RWL2 LED WALLPACK

ORDERING GUIDE

CATALOG #:

Series	# LEDs - Wattage	CCT/CRI	Distribution	Voltage	Color
RWL1 Micro Strike Optics	48L-10 1,000 Lumens	3K7 3000K, 70 CRI	2 ES TYPE II	UNV 120 277V	BLT Black Matte Textured
	48L-15 2,500 Lumens	4K7 4000K, 70 CRI	3 ES TYPE II	120 120V	BLS Black Gloss Smooth
	48L-20 2,500 Lumens**	5K7 5000K, 70 CRI	4 ES TYPE IV Forward	208 208V	DBT Dark Bronze Matte Textured
	48L-25 3,500 Lumens	3K8 3000K, 80 CRI	4 ES TYPE IV Wides	240 240V	DSB Dark Bronze Gloss Smooth
	48L-35 4,500 Lumens	4K8 4000K, 80 CRI		277 277V	DTT Graphite Matte Textured
	48L-45 5,500 Lumens**	5K8 5000K, 80 CRI		347 347V	LGS Light Grey Gloss Smooth
RWL2 Micro Strike Optics	16L-10 1,000 Lumens			480 480V	LEB Light Grey Matte Textured
	16L-15 1,500 Lumens				PLB Platinum Gloss Smooth
	16L-20 1,500 Lumens				PLS Platinum Silver Smooth
	16L-25 1,500 Lumens				WHB White Gloss Smooth
	16L-35 1,500 Lumens				WHT White Matte Textured
	16L-45 1,500 Lumens				WHG White Gloss Smooth
RWL2 Silk Optics	36L-10 1,000 Lumens, Side				VGB Vero Green Textured
	36L-15 2,500 Lumens, Side				CC Custom Color
	36L-20 2,500 Lumens, Side				
	36L-25 3,500 Lumens, Side				
	36L-35 5,000 Lumens, Side				
	36L-45 5,000 Lumens, Side				