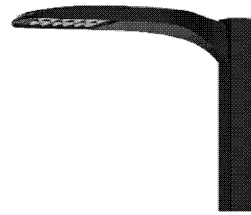
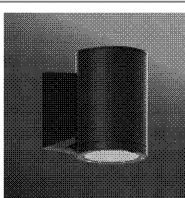
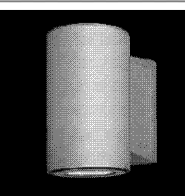
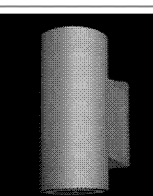



1. SITE LIGHTING FIXTURES TO BE CONTROLLED VIA LIGHTING RELAY CABINET INTERIOR TO BUILDING. FIXTURES TO BE ON FROM DUSK TO DAWN AND CONTROLLED VIA ROOF MOUNTED PHOTOCELL..
2. SITE LIGHT FIXTURES TO BE MOUNTED ON SQUARE STEEL POLE. REFER TO LIGHT FIXTURE SCHEDULE FOR ADDITIONAL DETAILS.

EXTERIOR LIGHT FIXTURE SCHEDULE							
TYPE	IMAGE	DESCRIPTION	MOUNTING	SOURCE	VOLTS	MANUFACTURER	V-A
S1		LED SITE LIGHT FIXTURE: P3 LED OPTICS, TYPE RCCO LIGHT DISTRIBUTION WITH BACKLIGHT CONTROL. SQUARE POLE MOUNTING. INTEGRAL PHOTOCELL. COORDINATE FIXTURE AND POLE FINISH WITH ARCHITECT.	15'-0" SQUARE STEEL POLE	LED 3000K 80CRI 9692 LM	UNV	ACUTY DSX1 SERIES OR APPROVED EQUAL	102
S2		LED SITE LIGHT FIXTURE: P3 LED OPTICS, TYPE LCCO LIGHT DISTRIBUTION WITH BACKLIGHT CONTROL. SQUARE POLE MOUNTING. INTEGRAL PHOTOCELL. COORDINATE FIXTURE AND POLE FINISH WITH ARCHITECT.	15'-0" SQUARE STEEL POLE	LED 3000K 80CRI 9692 LM	UNV	ACUTY DSX1 SERIES OR APPROVED EQUAL	102
S3		LED SITE LIGHT FIXTURE: P3 LED OPTICS, TYPE T2M LIGHT DISTRIBUTION WITH BACKLIGHT CONTROL. SQUARE POLE MOUNTING. INTEGRAL PHOTOCELL. COORDINATE FIXTURE AND POLE FINISH WITH ARCHITECT.	15'-0" SQUARE STEEL POLE	LED 3000K 80CRI 13055 LM	UNV	ACUTY DSX1 SERIES OR APPROVED EQUAL	102
S4		LED SITE LIGHT FIXTURE: P3 LED OPTICS, TYPE T1TM LIGHT DISTRIBUTION WITH HOUSESIDE SHIELD. SQUARE POLE MOUNTING. INTEGRAL PHOTOCELL. COORDINATE FIXTURE AND POLE FINISH WITH ARCHITECT.	15'-0" SQUARE STEEL POLE	LED 3000K 80CRI 13496 LM	UNV	ACUTY DSX1 SERIES OR APPROVED EQUAL	102
S5		LED SITE LIGHT FIXTURE: P7 LED OPTICS, TYPE T1TM LIGHT DISTRIBUTION WITH HOUSESIDE SHIELD. SQUARE POLE MOUNTING. INTEGRAL PHOTOCELL. COORDINATE FIXTURE AND POLE FINISH WITH ARCHITECT.	15'-0" SQUARE STEEL POLE	LED 3000K 80CRI 21778 LM	UNV	ACUTY DSX1 SERIES OR APPROVED EQUAL	184
S6		LED SITE LIGHT FIXTURE: P4 LED OPTICS, TYPE T4M LIGHT DISTRIBUTION WITH HOUSESIDE SHIELD. SQUARE POLE MOUNTING. INTEGRAL PHOTOCELL. COORDINATE FIXTURE AND POLE FINISH WITH ARCHITECT.	15'-0" SQUARE STEEL POLE	LED 3000K 80CRI 15613 LM	UNV	ACUTY DSX1 SERIES OR APPROVED EQUAL	124
L		6" DIA. LED EXTERIOR DOWNLIGHT. WET LOCATION LISTED. COORDINATE FINISH WITH ARCHITECT. PROVIDE WITH COMPATIBLE HOUSING.	RECESSED	LED 2000LM 3500K	UNV	NORA NLCB-652 OR APPROVED EQUAL	27
UD-1		7" CYLINDRICAL UP/DOWN LIGHT. BLACK FINISH. FROSTED LENS, ASYMMETRICAL HOUSING. WET LOCATION LISTED.	SURFACE WALL	LED 2X2541 LM 3500K	UNV	LIGMAN UTA-31883	54
WF1		8" CYLINDRICAL UP/DOWN LIGHT. BRONZE FINISH. FROSTED LENS, 12 DEGREE NARROW OPTICS. WET LOCATION LISTED.	SURFACE WALL	LED 4315 LM 3500K	UNV	LUMINIS SYRIOS 802	43
WF2		8" CYLINDRICAL UP LIGHT. BRONZE FINISH. FROSTED LENS, 28 DEGREE FLOOD OPTICS. WET LOCATION LISTED.	SURFACE WALL	LED 3572 LM 3500K	UNV	LUMINIS SYRIOS 800	40


ILLUMINANCE LEVELS (FC)					
AREA	AVERAGE	MAXIMUM	MINIMUM	AVG/MIN	MAX/MIN
PARKING	2.97	9.90	0.20	14.80	49.50
PROPERTY LINE	0.27	1	0	NA	NA

NOTES:

1. ILLUMINANCE VALUES ARE IN FC.
2. MAINTANCE FACTOR OF 0.9 WAS USED AS FIXTURES ARE LED

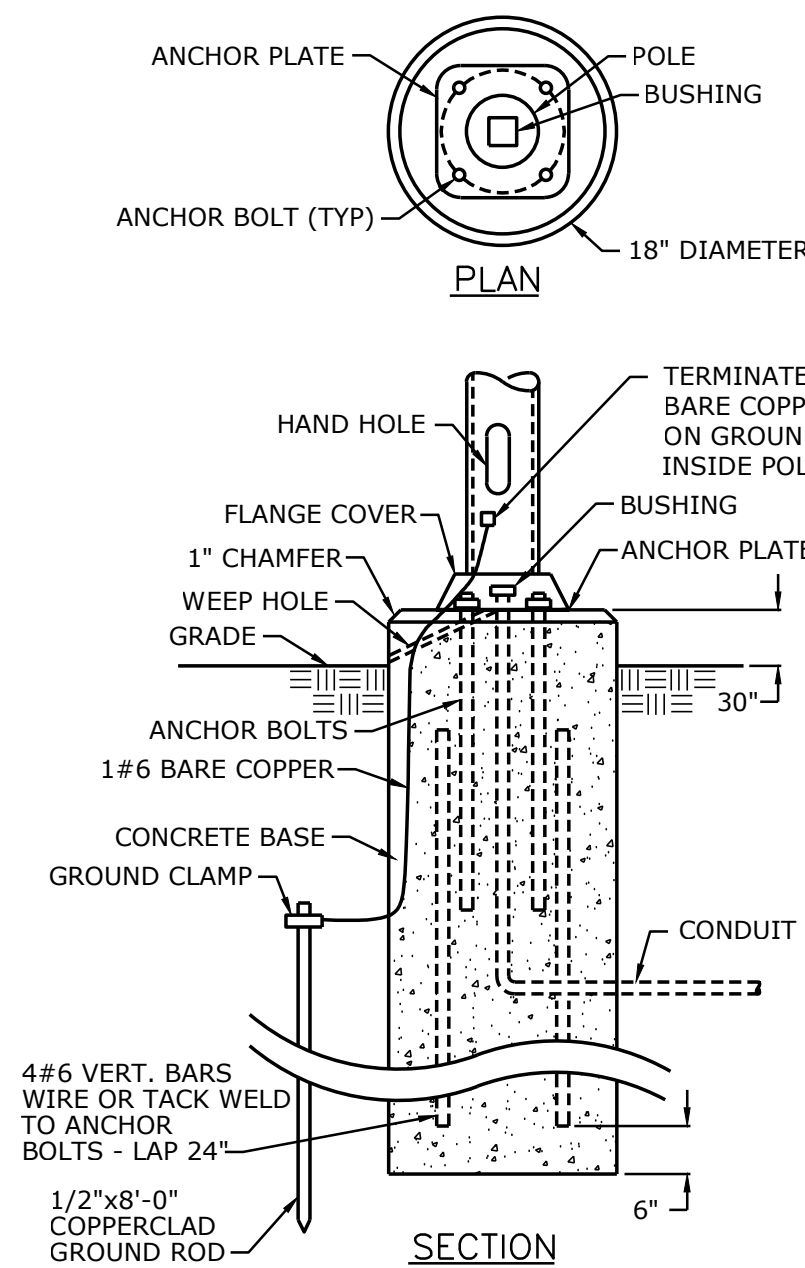

POLE BASE
NOT TO SCALE

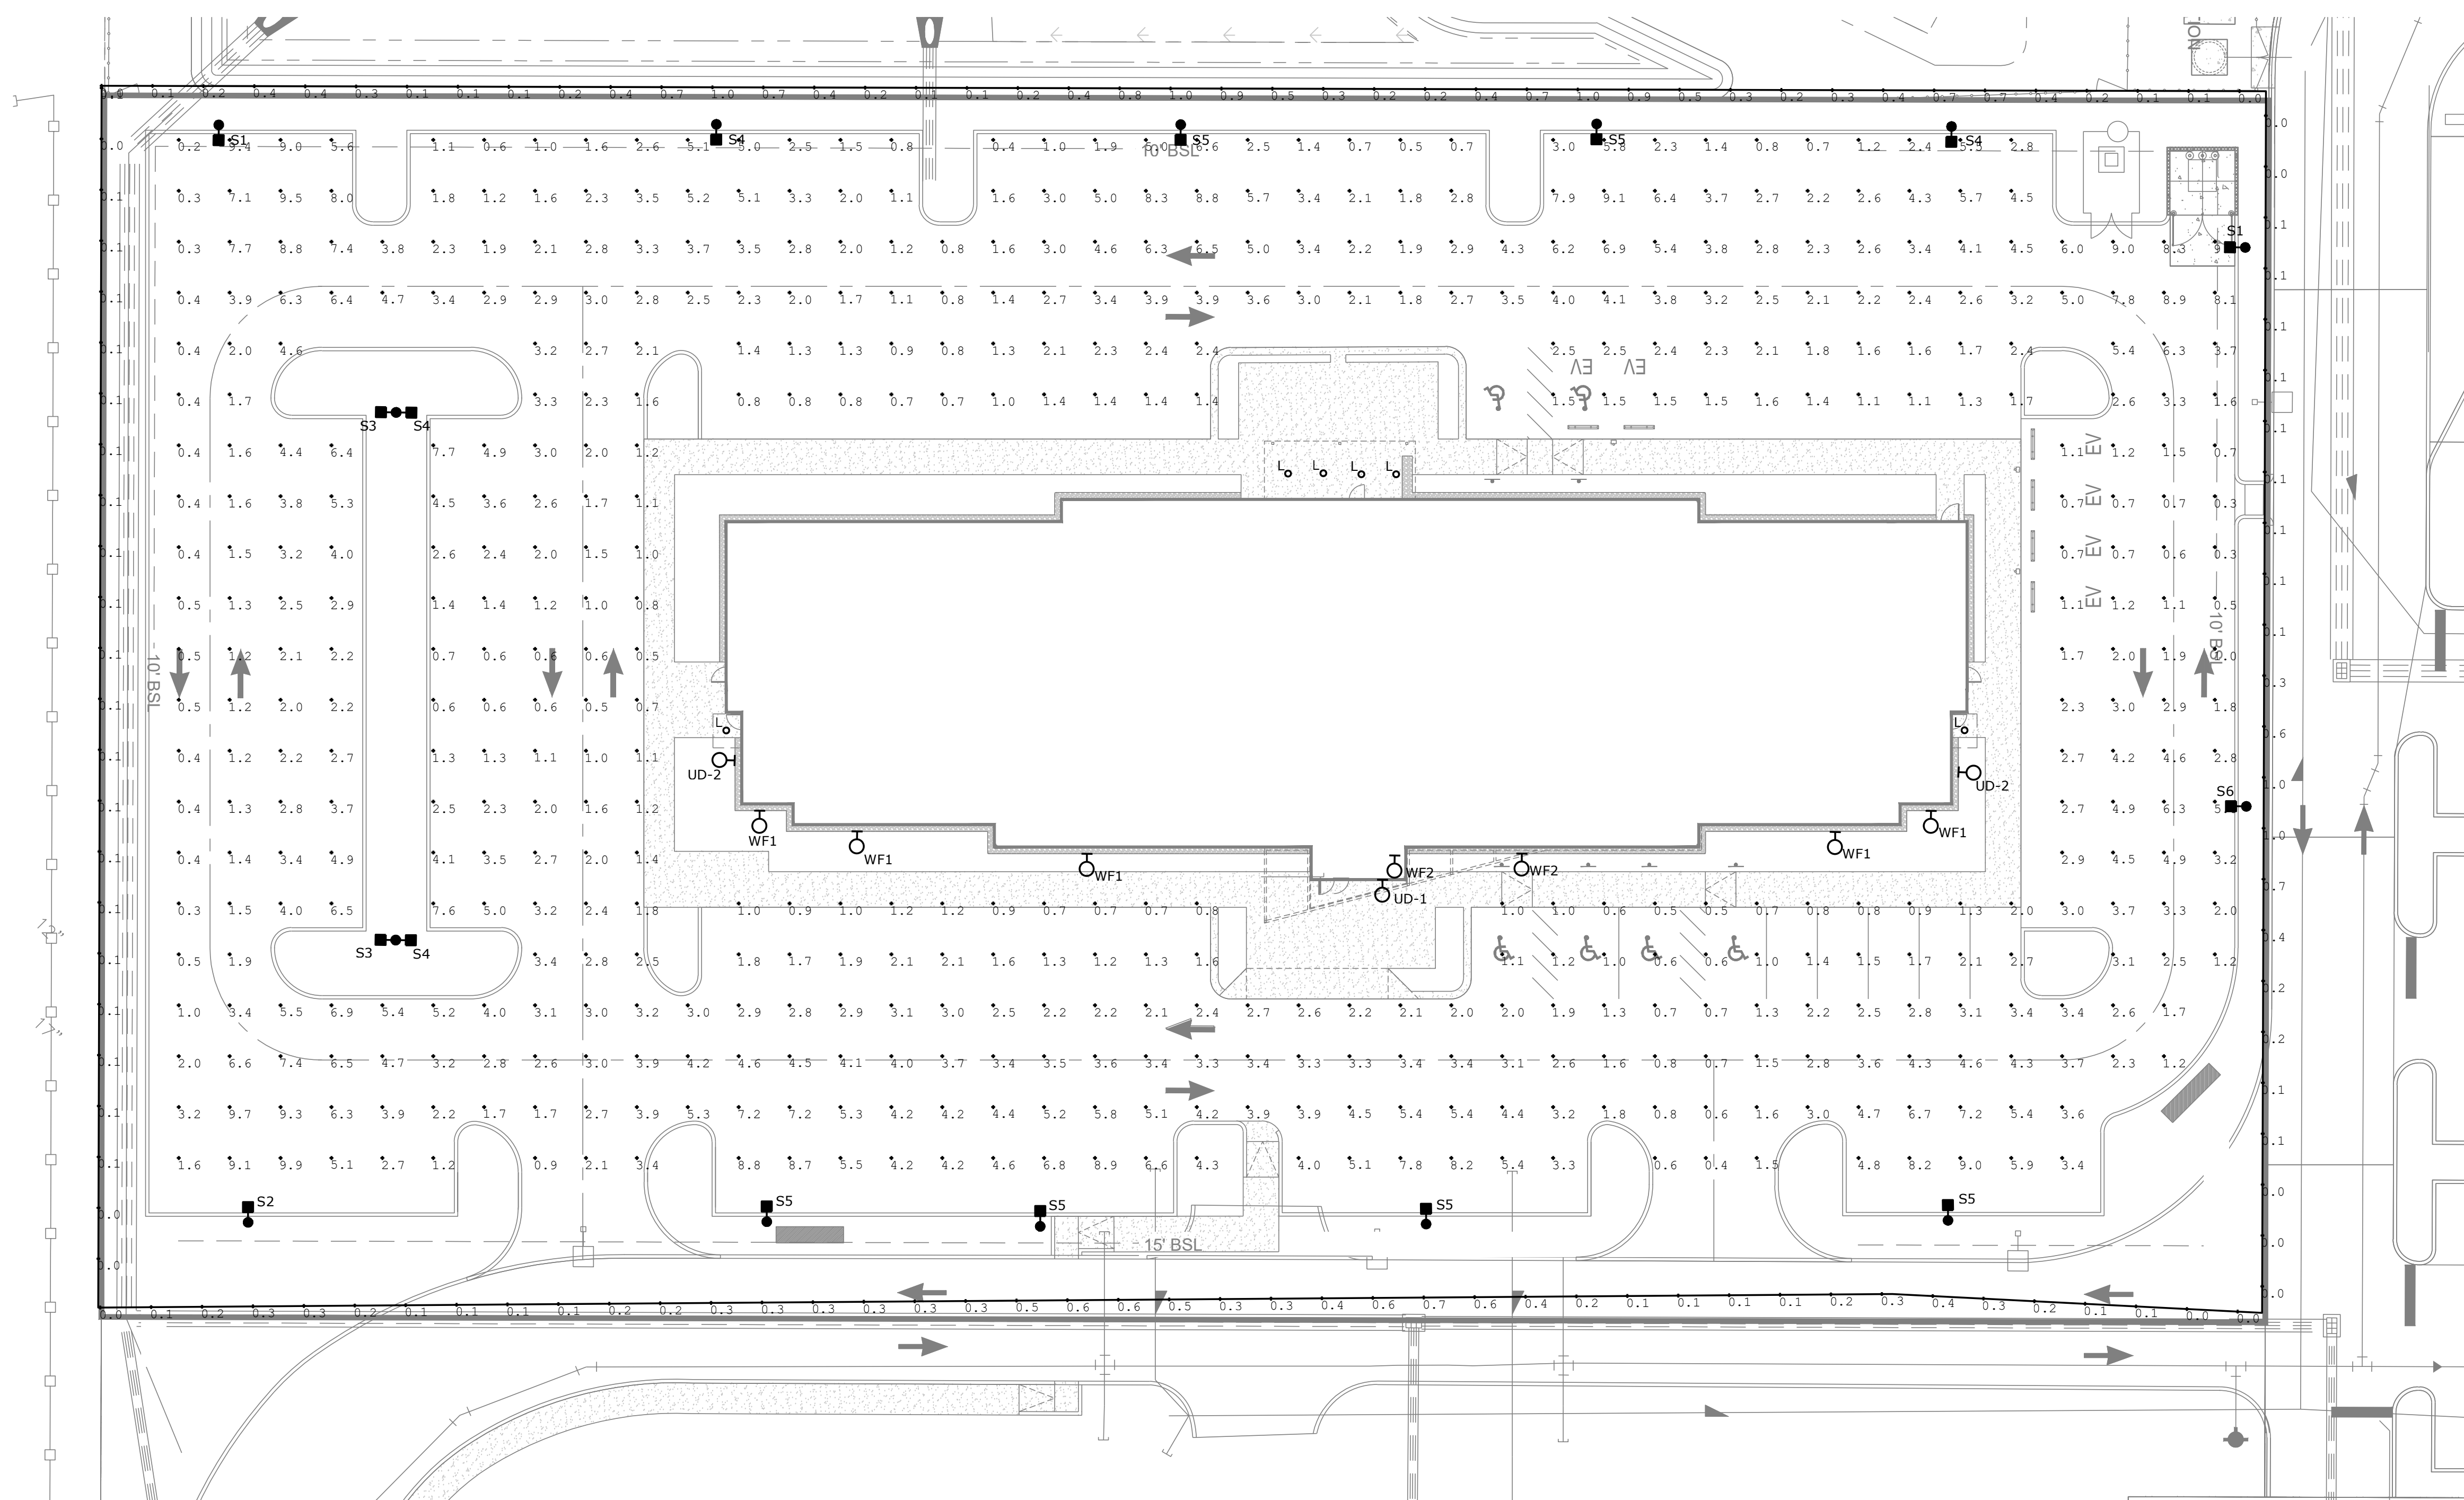

 **PHOTOMETRICS - SITE PLAN**
SCALE: 1"=20'-0"

2314604 Hyatt Studios - Venice, FL
 XXXXX12312314604?ref=app/01-2314604_MG21P - PHOTO METRCS - SITE PLAN.dwg
 Thursday, March 27, 2025 2:39:13 PM
 Thursday, March 27, 2025 2:40:15 PM

PROJECT NAME:
AUTOCAD FILE LOCATION \ NAME:
LAST CORRECTION BY ♦ DATE ♦ TIME:
PLOTTED BY ♦ DATE ♦ TIME: