


128 CASTILLE AVE

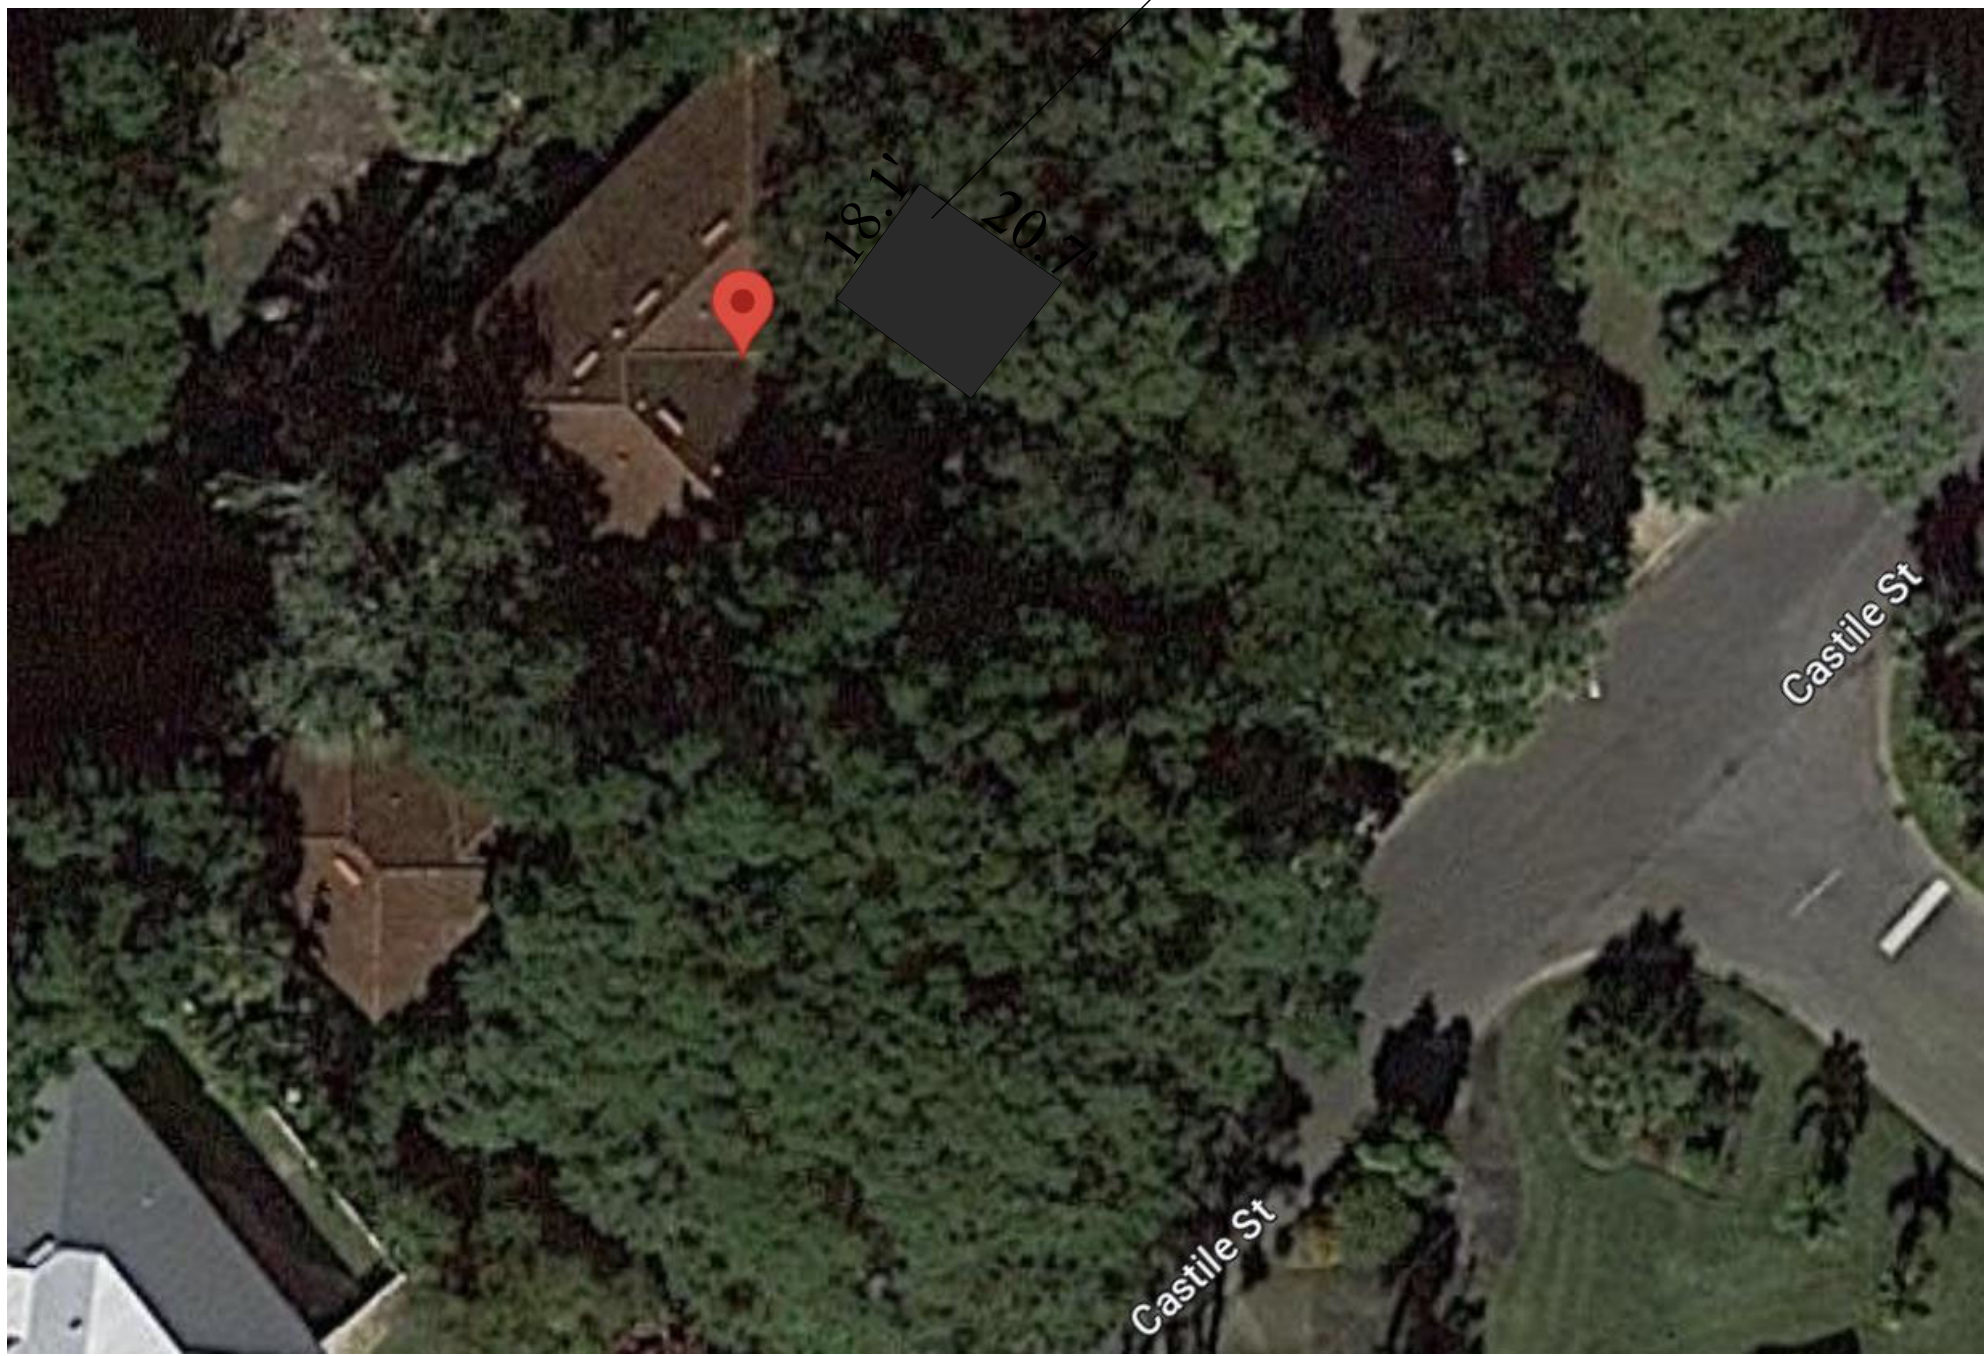


SITE PLAN

NORTH

LOCATION OF 22'8"X18'2" (412 SF)
COVERED CARPORT OVER
EXISTING CONCRETE DRIVE.
NO CHANGES TO IMPERVIOUS
SURFACE ARE BEING MADE.


PROJECT INFO:
128 CASTILLE ST VENICE FL
CITY OF VENICE
LOT SIZE 17,250 SF
EXISTING BUILDING COVERAGE 3,827 SF
PROPOSED 412 SF COVERED CARPORT
NEW BUILDING COVERAGE 4,238 SF (24.5%)
IMPERVIOUS SURFACE--NO CHANGES

SCOPE:
- INTERIOR REMODEL BATHS AND KITCHEN
- REPLACE ALL WINDOWS AND DOORS
- REMOVE AND REPLACE ROOF
- INSTALL NEW GAS FIREPLACE
-NEW DETACHED CARPORT
-REPIPE WATER LINES

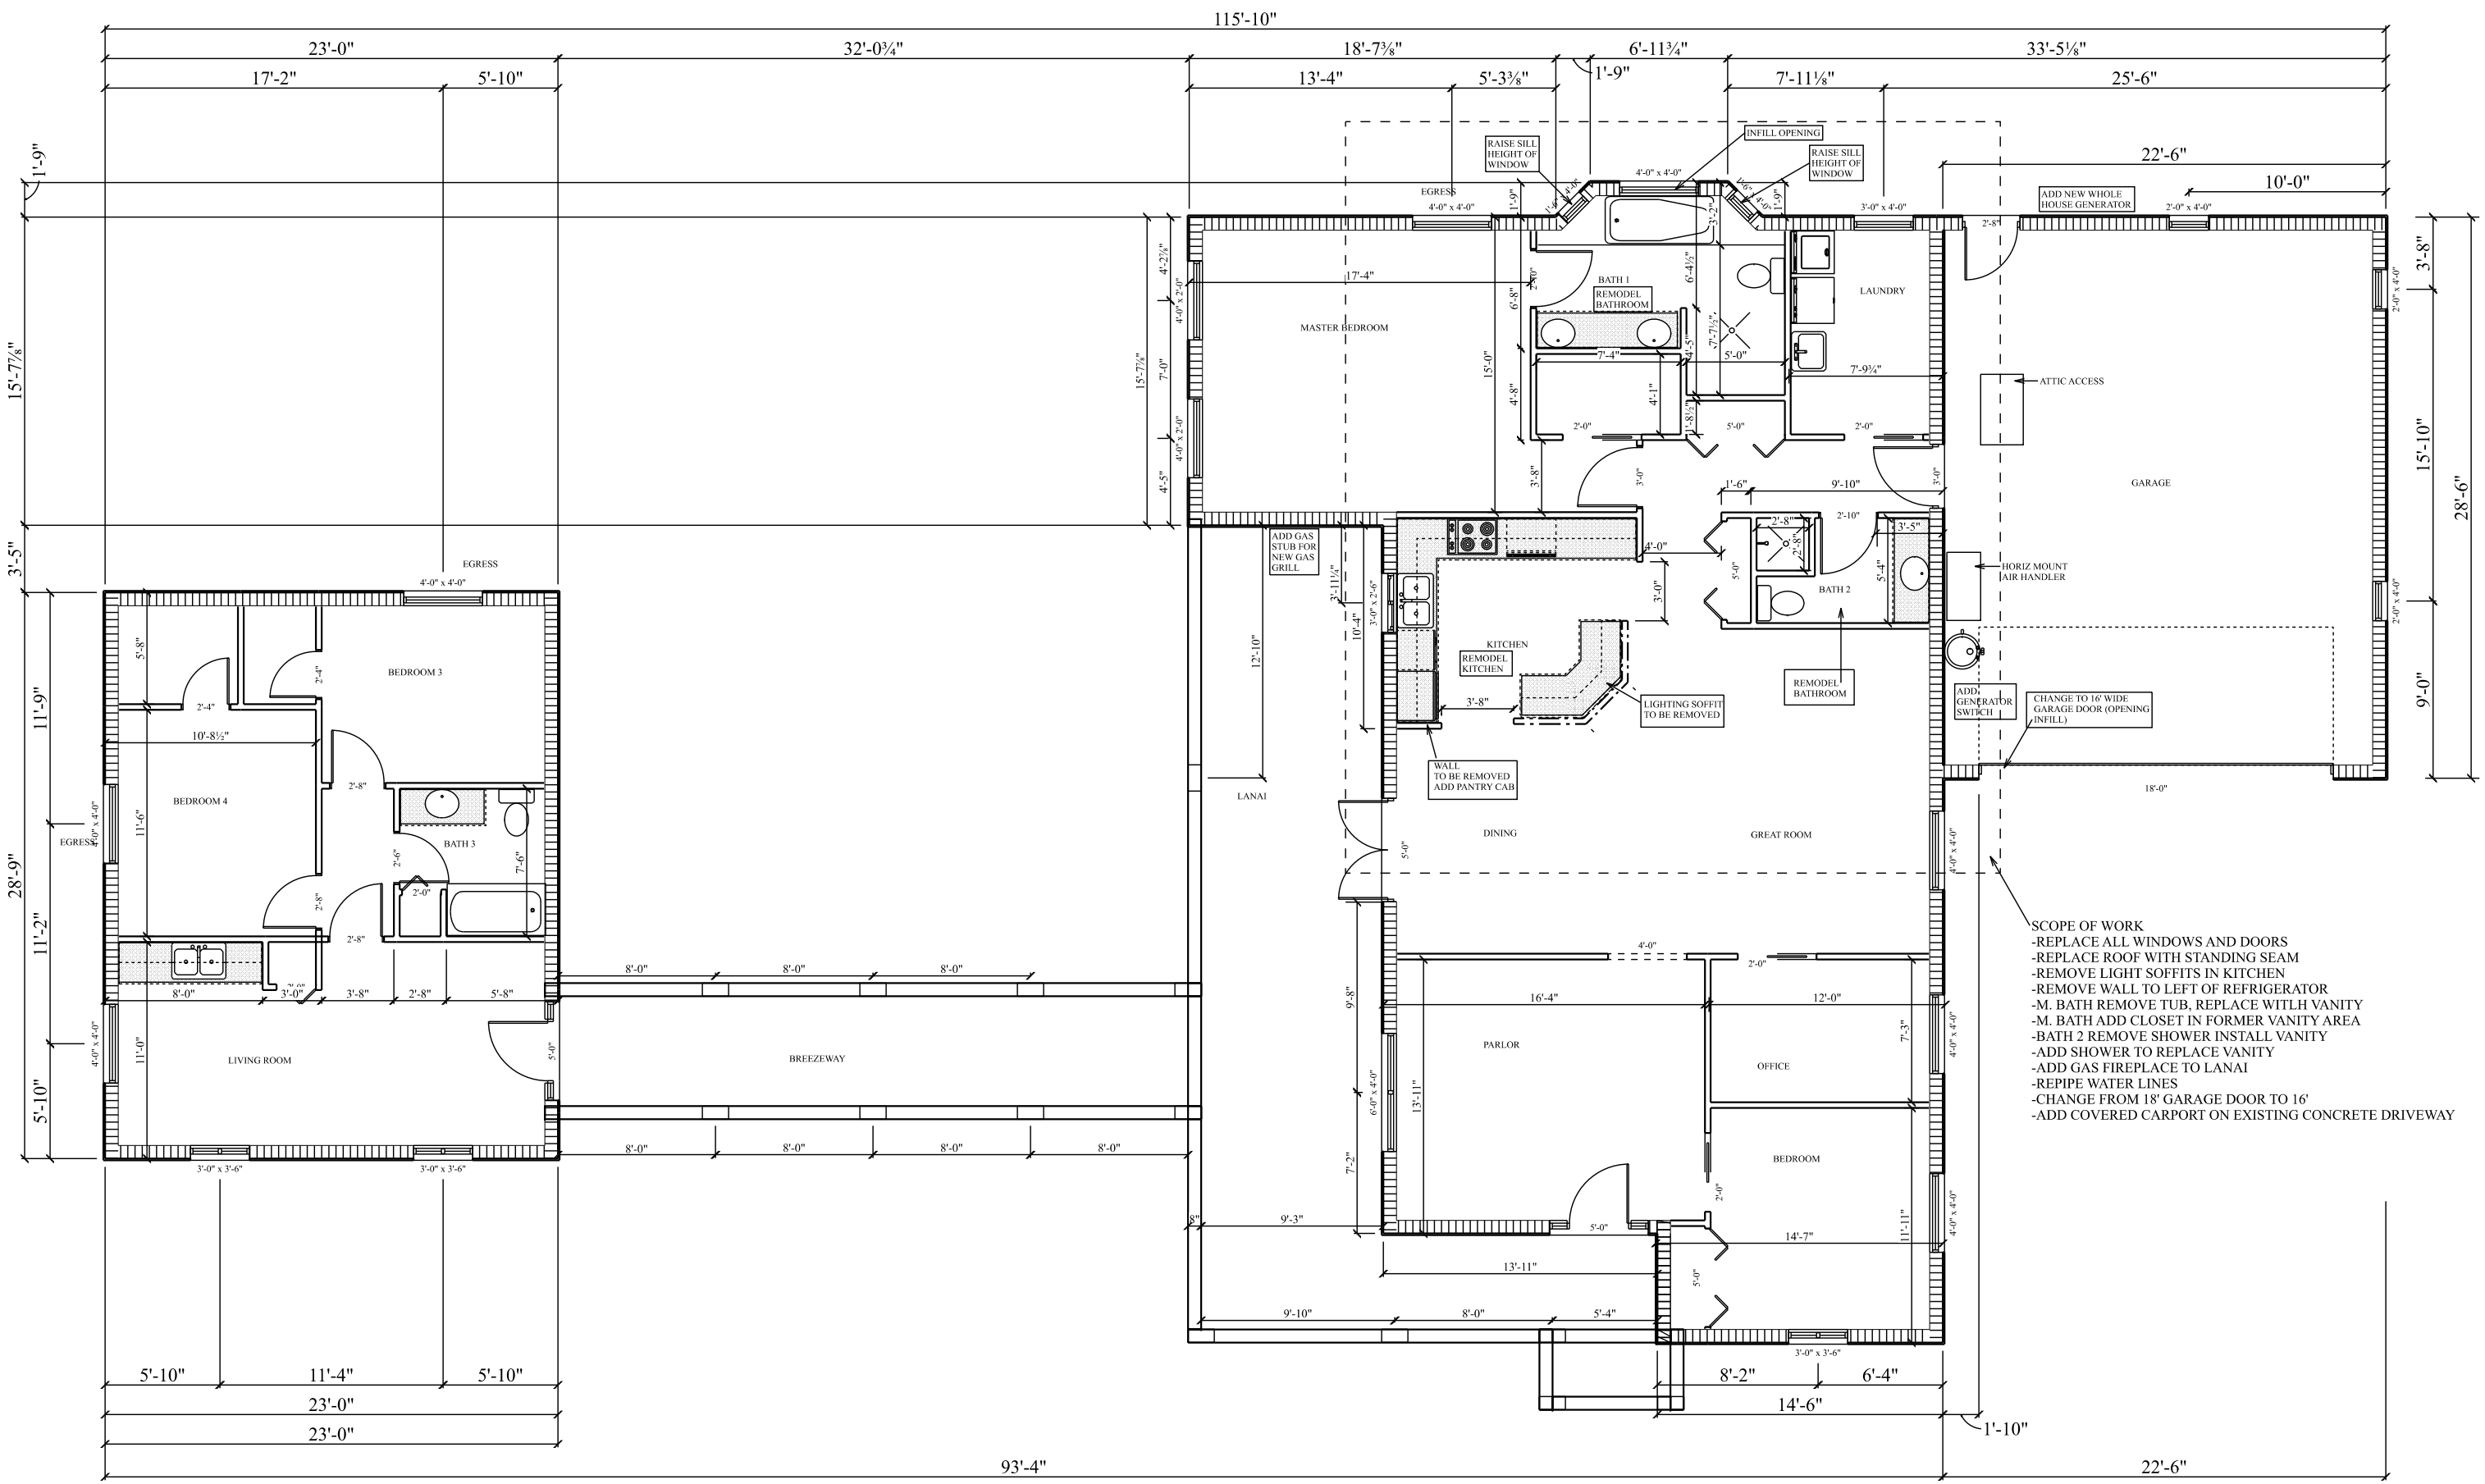


EXISTING FLOORPLAN

SCALE: 1/8" = 1'-0"

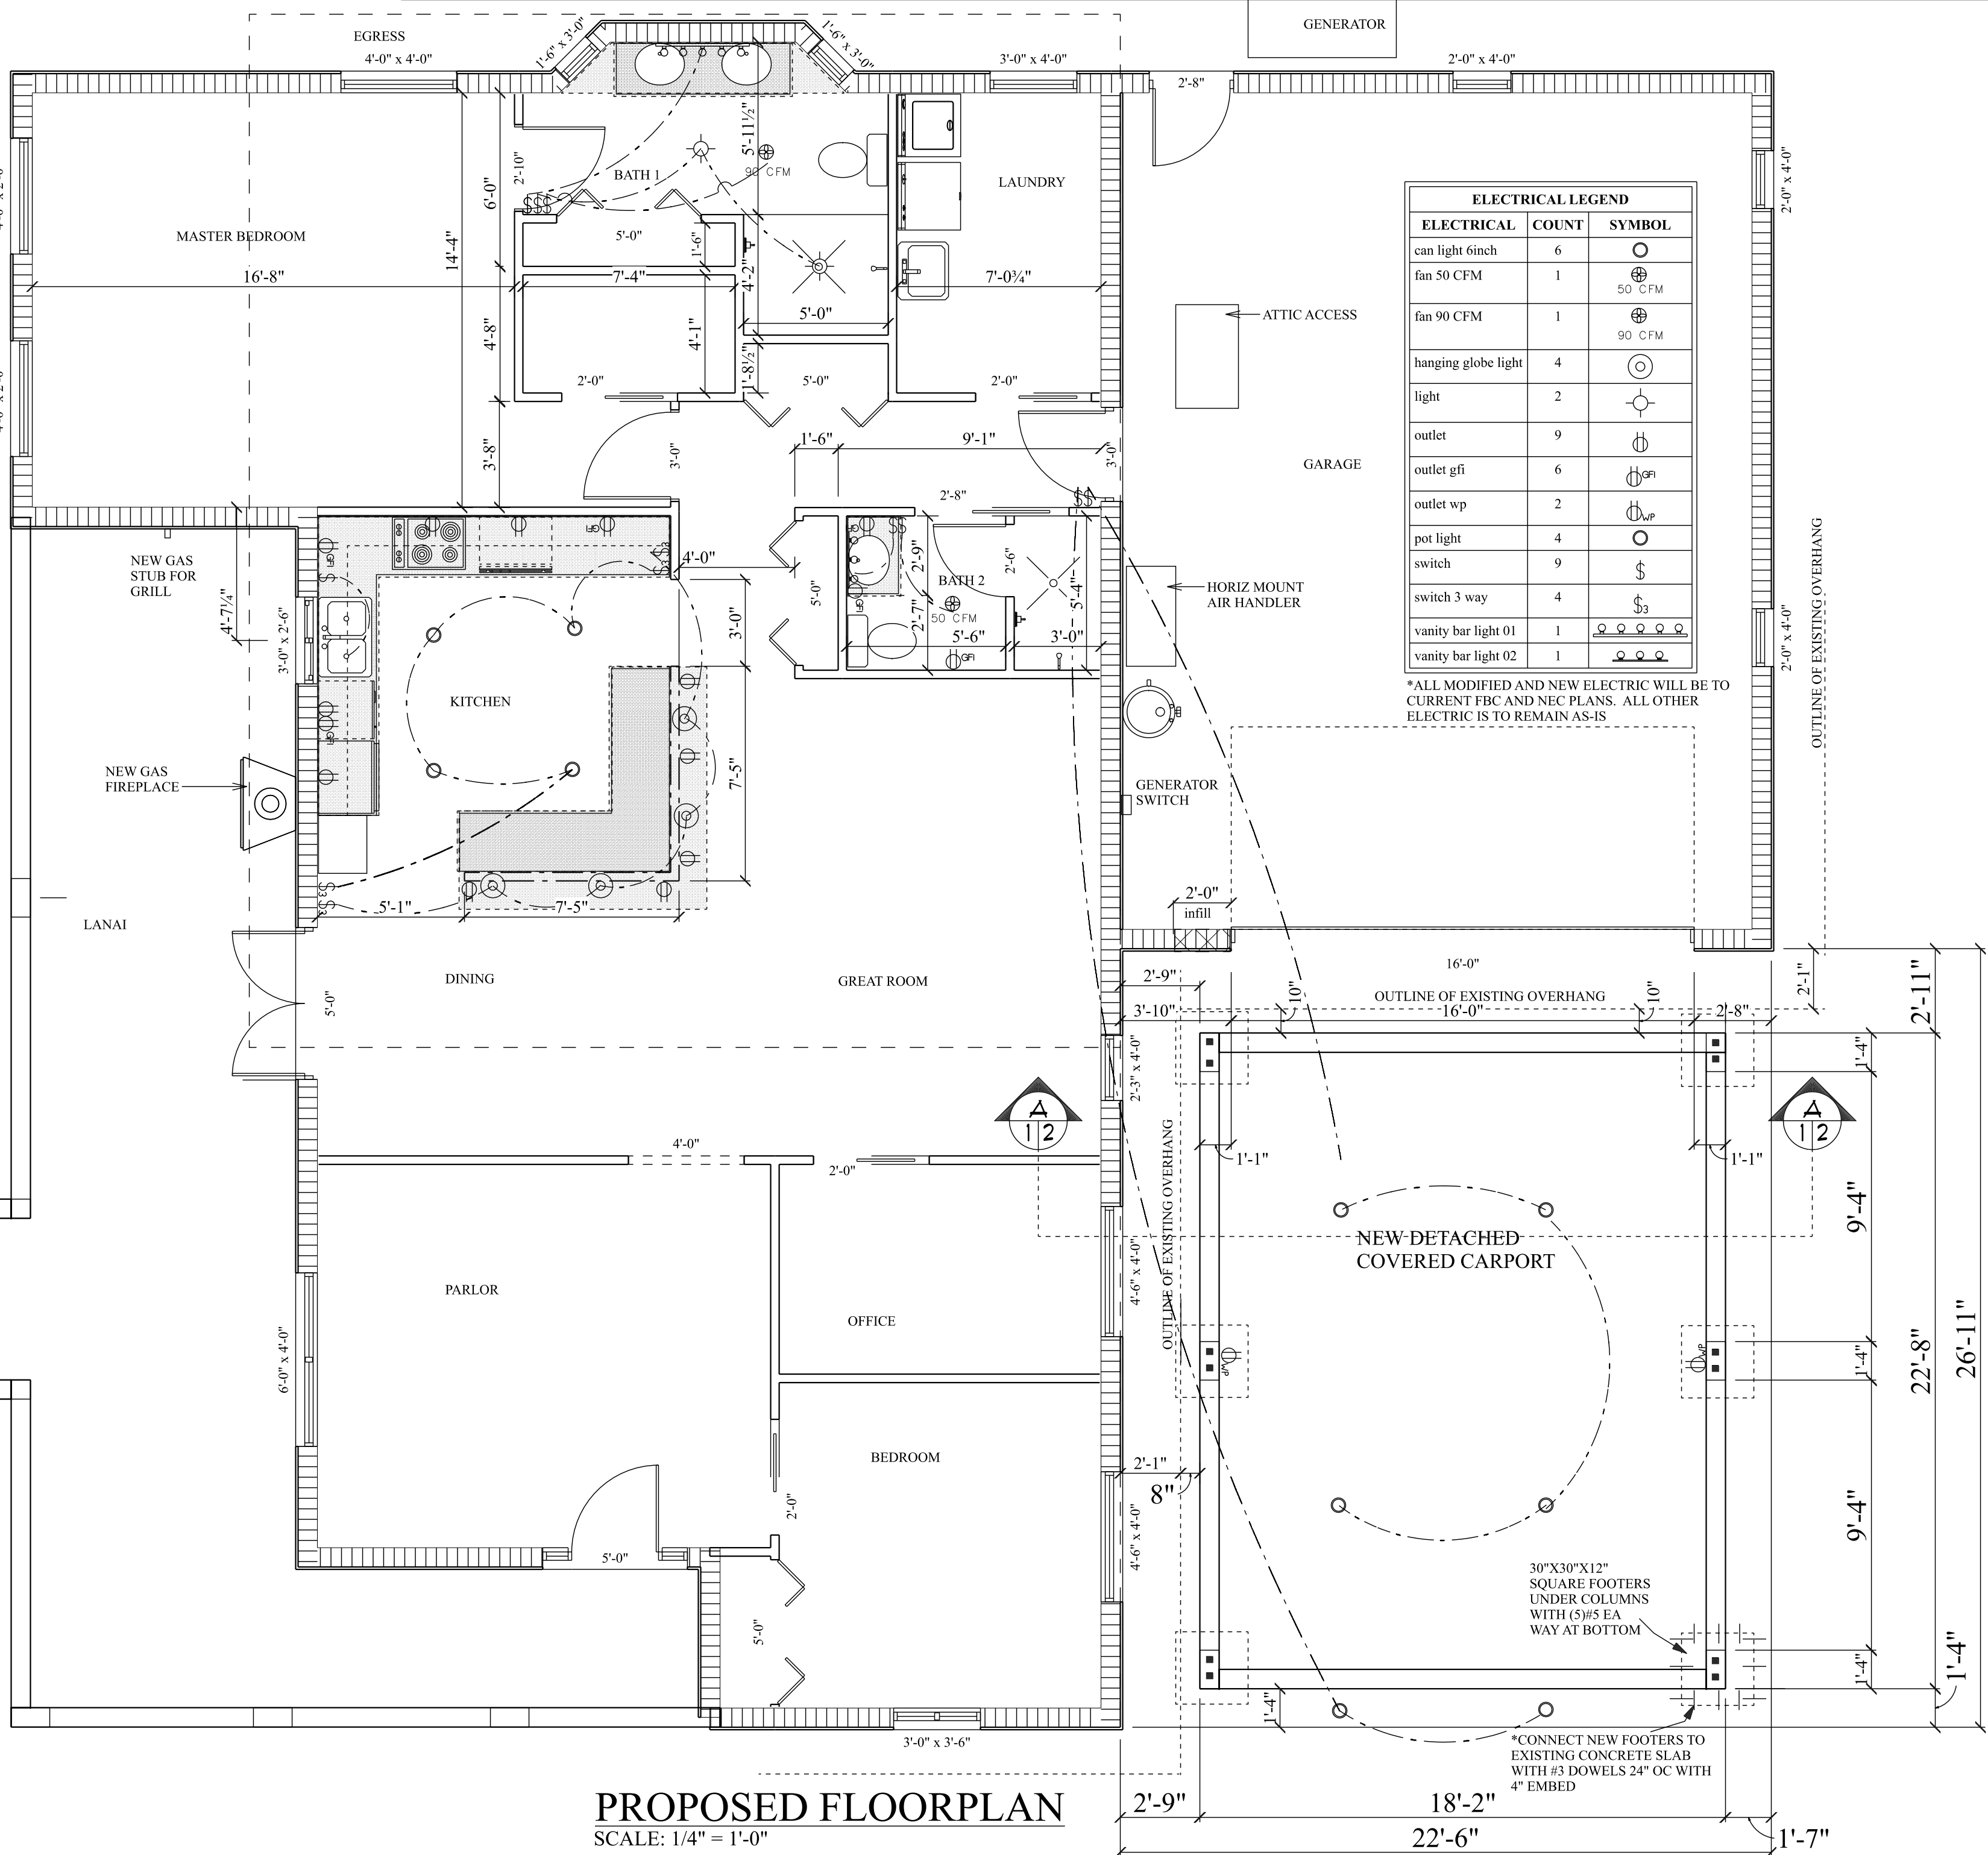

PROPOSED FLOORPLAN


SCALE: 1/4" = 1'-0"

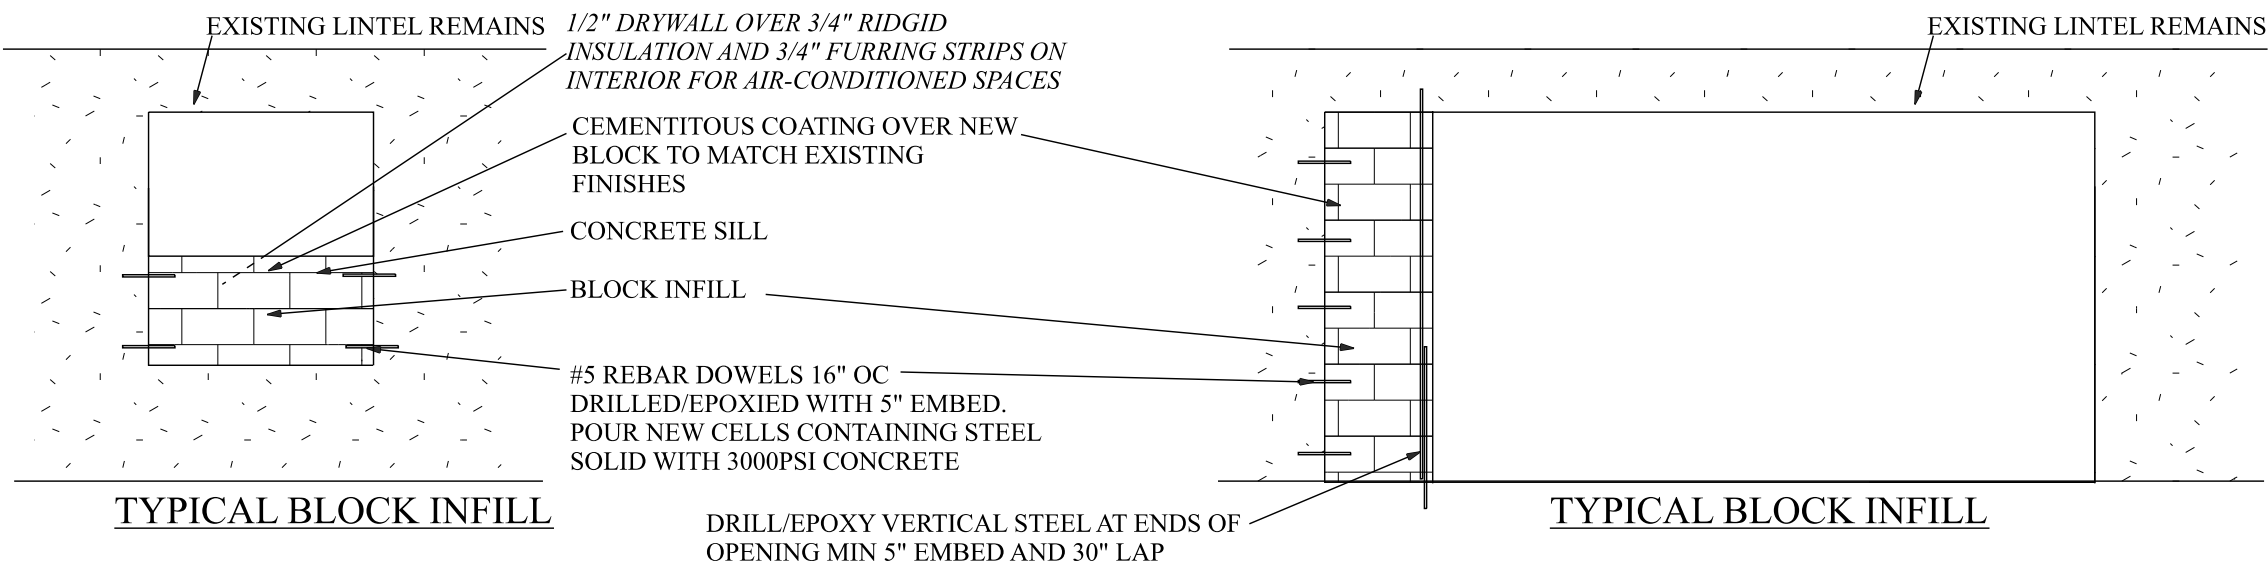

BUILDING DATA

**THIS DRAWING AND DESIGN IS VALID FOR 12 MONTHS AFTER IT IS SIGNED/SEALED. SCALES ARE ACCURATE ON 24\"/>

G&C ZONES

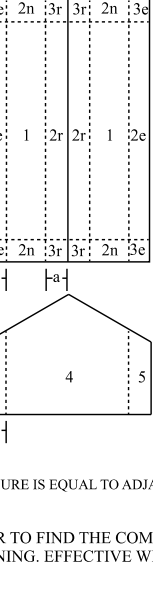

STRUCTURAL DESIGN CRITERIA

CORRS: FLORIDA BUILDING CODE, 2007-7th ed. ASCE 7-10 DESIGN CRITERIA
CONCRETE: 3000 PSI, 3\"/>

ELECTRICAL

1. Outlet heights as measured from finished floor to bottom of box is 12\"/>

ELECTRICAL LEGEND

ELECTRICAL	COUNT	SYMBOL
can light 6inch	1	⊙
fan 50 CFM	6	⊕
fan 90 CFM	1	⊕
hanging globe light	4	⊙
light	2	⊙
outlet	9	⊕
outlet gfi	6	⊕
outlet wp	2	⊕
pot light	4	⊕
switch	9	⊕
switch 3 way	4	⊕
vanity bar light 01	1	⊕
vanity bar light 02	1	⊕

*ALL MODIFIED AND NEW ELECTRIC WILL BE TO CURRENT FBC AND NEC PLANS. ALL OTHER ELECTRIC IS TO REMAIN AS-IS.