



LEGEND

| PROPOSED | EXISTING |
|------------------------------|------------------------------|
| W | WATER MAIN |
| F | FIRE MAIN |
| RWFM | RECLAIMED WATER FORCEMAIN |
| REDUCER | REDUCER |
| TEMPORARY BLOWOFF | TEMPORARY BLOWOFF |
| FIRE HYDRANT | FIRE HYDRANT |
| GATE VALVE (G.V. & BOX) | GATE VALVE (G.V. & BOX) |
| SIAMSE CONNECTION | SIAMSE CONNECTION |
| DOUBLE CHECK ASSEMBLY | DOUBLE CHECK ASSEMBLY |
| WATER METER | WATER METER |
| SANITARY SEWER LINE | SANITARY SEWER LINE |
| SANITARY SEWER FORCEMAIN | SANITARY SEWER FORCEMAIN |
| SANITARY SEWER MANHOLE | SANITARY SEWER MANHOLE |
| CLEAN OUT | CLEAN OUT |
| STORM DRAIN | STORM DRAIN |
| ROOF DRAIN | ROOF DRAIN |
| GRATE INLET | GRATE INLET |
| JUNCTION BOX | JUNCTION BOX |
| EROSION CONTROL | EROSION CONTROL |
| OUTFALL STRUCTURE | OUTFALL STRUCTURE |
| MITERED END SECTION (M.E.S.) | MITERED END SECTION (M.E.S.) |
| TOP OF BANK | TOP OF BANK |
| FENCE | FENCE |
| EASEMENT OR SETBACK | EASEMENT OR SETBACK |
| TRAFFIC FLOW ARROW | TRAFFIC FLOW ARROW |
| HANDICAP PARKING SPACE | HANDICAP PARKING SPACE |
| H.P. OR CHANGE IN SLOPE | H.P. OR CHANGE IN SLOPE |
| ELEVATION | ELEVATION |

CONTRACTOR TO CALL "SUNSHINE" AT 1-800-432-4770,
48 hrs. PRIOR TO ANY CLEARING OR CONSTRUCTION
FOR EXISTING UTILITY LOCATIONS.

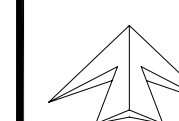

NORTH

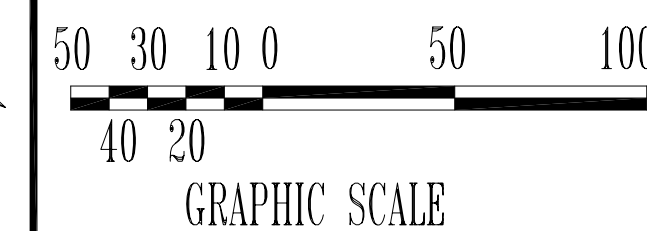

APPROXIMATE LOCATION
OF EXISTING BRIDGE
COLUMN (TYP). (TO BE PERMITTED BY OTHERS)

PROPOSED 10'x18'
GRAVEL PARKING
SPACES (TYP) (TO BE PERMITTED BY OTHERS)

EXISTING CURB AT DRIVEWAY
LOCATIONS TO BE REMOVED AND
REPLACED WITH F.D.O.T. DROP CURB (TYP)
(TO BE PERMITTED BY OTHERS)

CLIENT:

FISHERMANS WHARF
OF VENICE, LLC
333 S. TAMiami TRAIL, SUITE 205
VENICE, FL. 34285

PROJECT NAME: SEC. 7 TWP. 39S RNG. 19E

FISHERMANS WHARF
SITE PLAN SHOWING PARKING UNDER BRIDGE

PROJECT NUMBER

16-2216

SCALE

1"=50'

NO. DATE BY

REVISIONS

©2017 by Professional
Engineering Resources, Inc.
All Rights Reserved
The arrangements depicted
herein are the sole property
of Professional Engineering
Resources, Inc. and may not
be reproduced in any form
without its written permission

PEER
PROFESSIONAL ENGINEERING RESOURCES, INC.
10225 ULMERTON ROAD, SUITE 4D LARGO, FL. 33771
CIVIL ENGINEERS, PLANNERS, PERMIT EXPEDITORS (727) 408-5207
CERTIFICATE OF AUTHORIZATION NUMBER: 4401

DRAWING TYPE

☐ PRELIMINARY
☒ CONSTRUCTION
☐ RECORD

DESIGNED BY: PVS

DRAWN BY: SAG

APPROVED

PAUL V. SHERMA, REG. NO. 35628

CHECKED BY: PVS

DATE: 6-5-17

SHEET NUMBER

1/1