


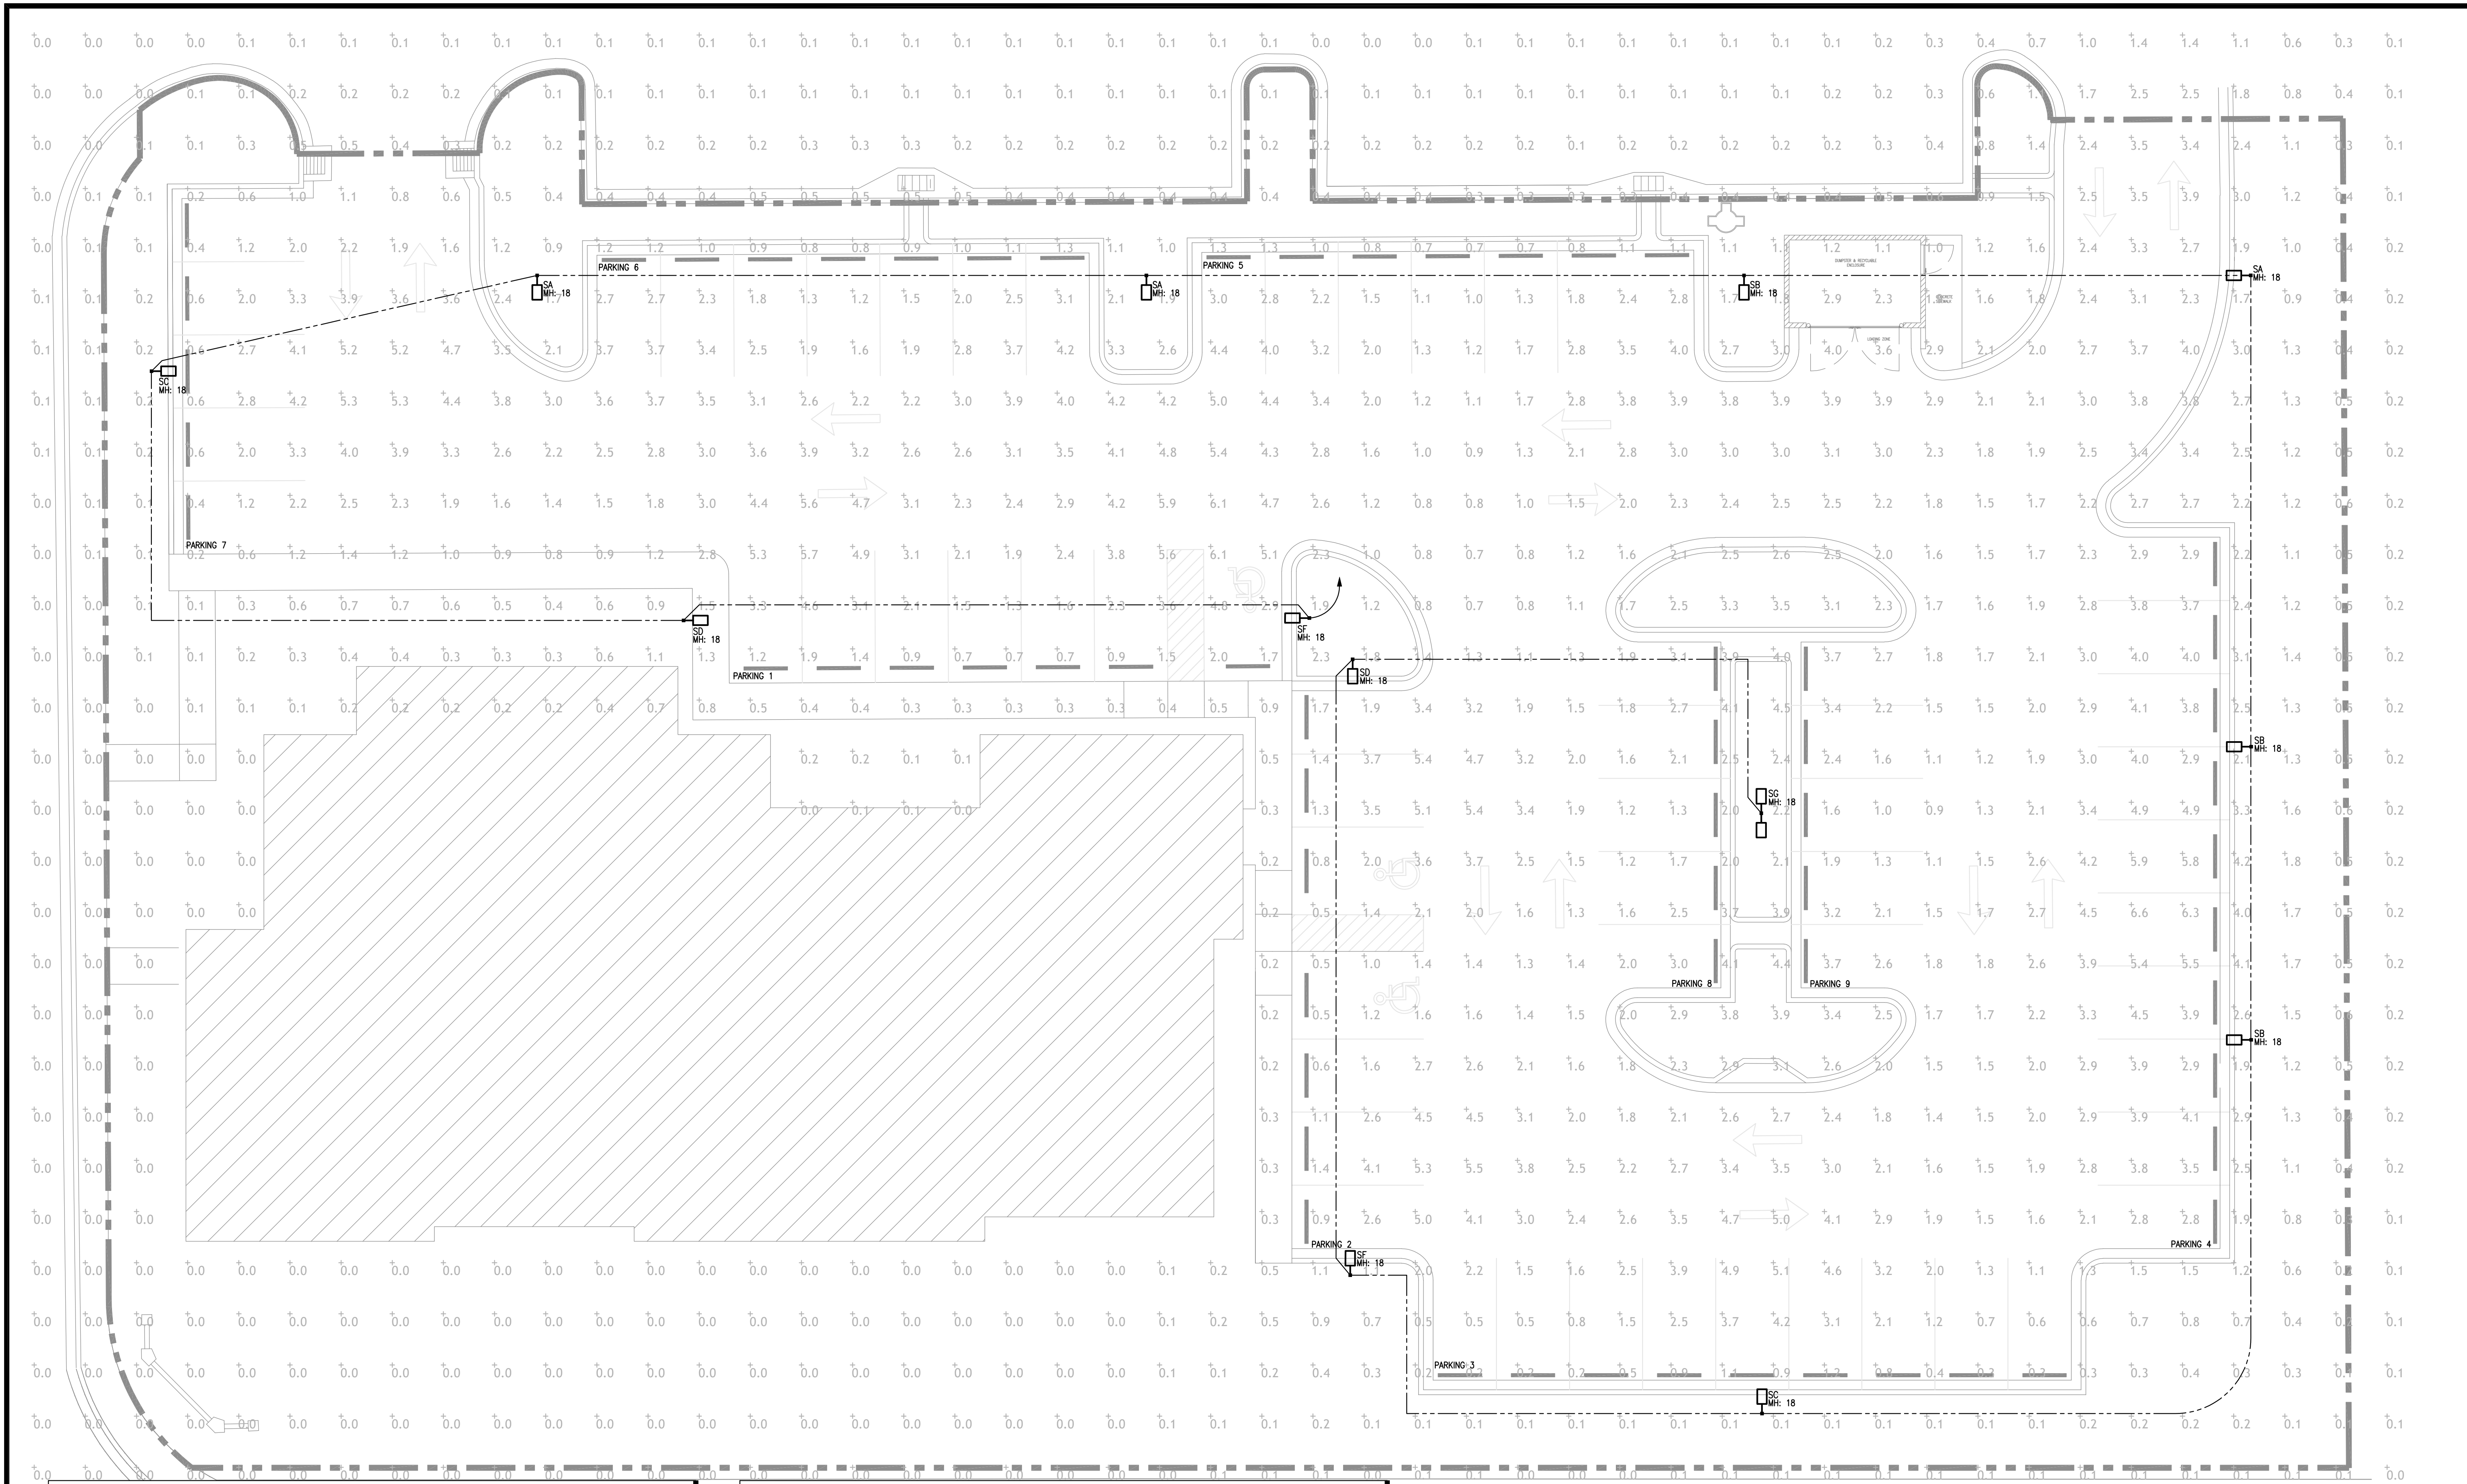

SITE LIGHTING FIXTURE SCHEDULE						
LABEL	MANUFACTURER	QTY	ARRANGMENT	LUMENS	LLF	WATTS
SA	AAL	3	SINGLE	8103	0.950	129.5
SB	AAL	3	SINGLE	7976	0.950	129.3
SC	AAL	1	SINGLE	5761	0.950	129.9
SD	AAL	2	SINGLE	4839	0.950	84
SF	AAL	2	SINGLE	4839	0.950	84
SG	AAL	1	BACK-BACK	10136	0.950	168
POLE	AAL	9	-	-	-	-
ARM	AAL	8	SINGLE	-	-	-
ARM	AAL	1	BACK-BACK	-	-	-
DESCRIPTION						
UCL/BEL/72-56LED/3K/700/DGN/SLA10						
UCL/BEL/73-56LED/3K/700/DGN/SLA10						
UCL/BEL/74-56LED/3K/700/DGN/HSS/SLA10						
UCL/BEL/TL-56LED/3K/450/DGN/SLA10						
UCL/BEL/TR-56LED/3K/450/DGN/SLA10						
UCL/BEL/74-56LED/3K/450/DGN/SLA10+2						
DB3/4R18-226						
SLA10						
SLA10-2						

CALCULATION SUMMARY						
LOCATION	CALCTYPE	UNITS	AVG	MAX	MIN	AVG/MIN
PARKING OVERALL	ILLUMINANCE	Fc	2.66	6.6	0.2	12.75
PARKING 1	ILLUMINANCE	Fc	2.03	4.8	0.7	2.90
PARKING 2	ILLUMINANCE	Fc	2.32	5.4	0.5	4.64
PARKING 3	ILLUMINANCE	Fc	1.73	5.1	0.2	8.65
PARKING 4	ILLUMINANCE	Fc	4.20	6.6	2.8	1.50
PARKING 5	ILLUMINANCE	Fc	2.40	4.4	1.0	2.40
PARKING 6	ILLUMINANCE	Fc	2.45	4.2	1.2	2.04
PARKING 7	ILLUMINANCE	Fc	1.72	4.2	0.2	8.60
PARKING 8	ILLUMINANCE	Fc	1.98	3.1	1.2	1.65
PARKING 9	ILLUMINANCE	Fc	2.39	3.7	1.0	2.39

PHOTOMETRIC NOTE

NOTE: THESE CALCULATIONS ARE FOR GUIDANCE ONLY. RESULTS DEPEND ON PROVIDED INFORMATION AND ANY CHANGE IN DIMENSIONS, COLORS, REFLECTANCE, TEXTURES OR OTHER PROPERTIES WILL AFFECT THE RESULTS. MEASURED VALUES MAY DIFFER FROM CALCULATED VALUES DUE TO CALCULATION METHODS AND/OR ENVIRONMENTAL CONDITIONS.

ELECTRICAL LIGHTING SITE PLAN - PHOTOMETRICS

SCALE : 3/32"=1'-0"

TO THE BEST OF THE ENGINEERS KNOWLEDGE, SAID PLANS AND SPECIFICATIONS COMPLY WITH THE APPLICABLE BUILDING CODES AND THE APPLICABLE MINIMUM FIRE SAFETY STANDARDS AS DETERMINED IN ACCORDANCE WITH CHAPTERS 553 AND 633, FLORIDA STATUTES.




Mark A. Beebe, AIA

825 S. Tamiami Trail • Suite 1
Venice • Florida 34275


941.484.6762

WWW.BEEBEDESIGNSTUDIO.COM

CONSULTANT

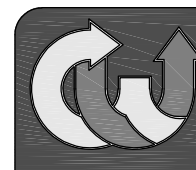

mechanical electrical plumbing & fire consultants
6885 PROFESSIONAL PKWY. E 34940
SPASSOFA FLORIDA
[941] 907-0055 Fax [941] 907-0582 GN 7029

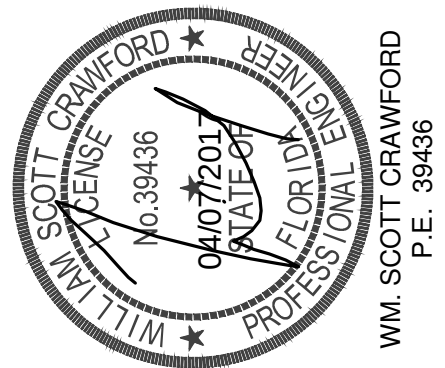

WM SCOTTCRAWFORD
P.E. 39438

PROJECT :
THE EYE ASSOCIATES - VENICE

ISSUED FOR :
SITE & DEVELOPMENT

PROJECT No. : 1610

No.	REVISION	DATE
△		
△		
△		
△		
△		

DRAWN BY :

CHECKED BY : WSC

DWG No. :

SCALE : AS SHOWN

PLOT DATE : 12/12/16

SHEET TITLE :
ELECTRICAL LIGHTING
SITE PLAN -
PHOTOMETRICS

SHEET NUMBER :

ES0.01