


C:\project\2018\181104-Laurel Apartments\Elec\01.dwg

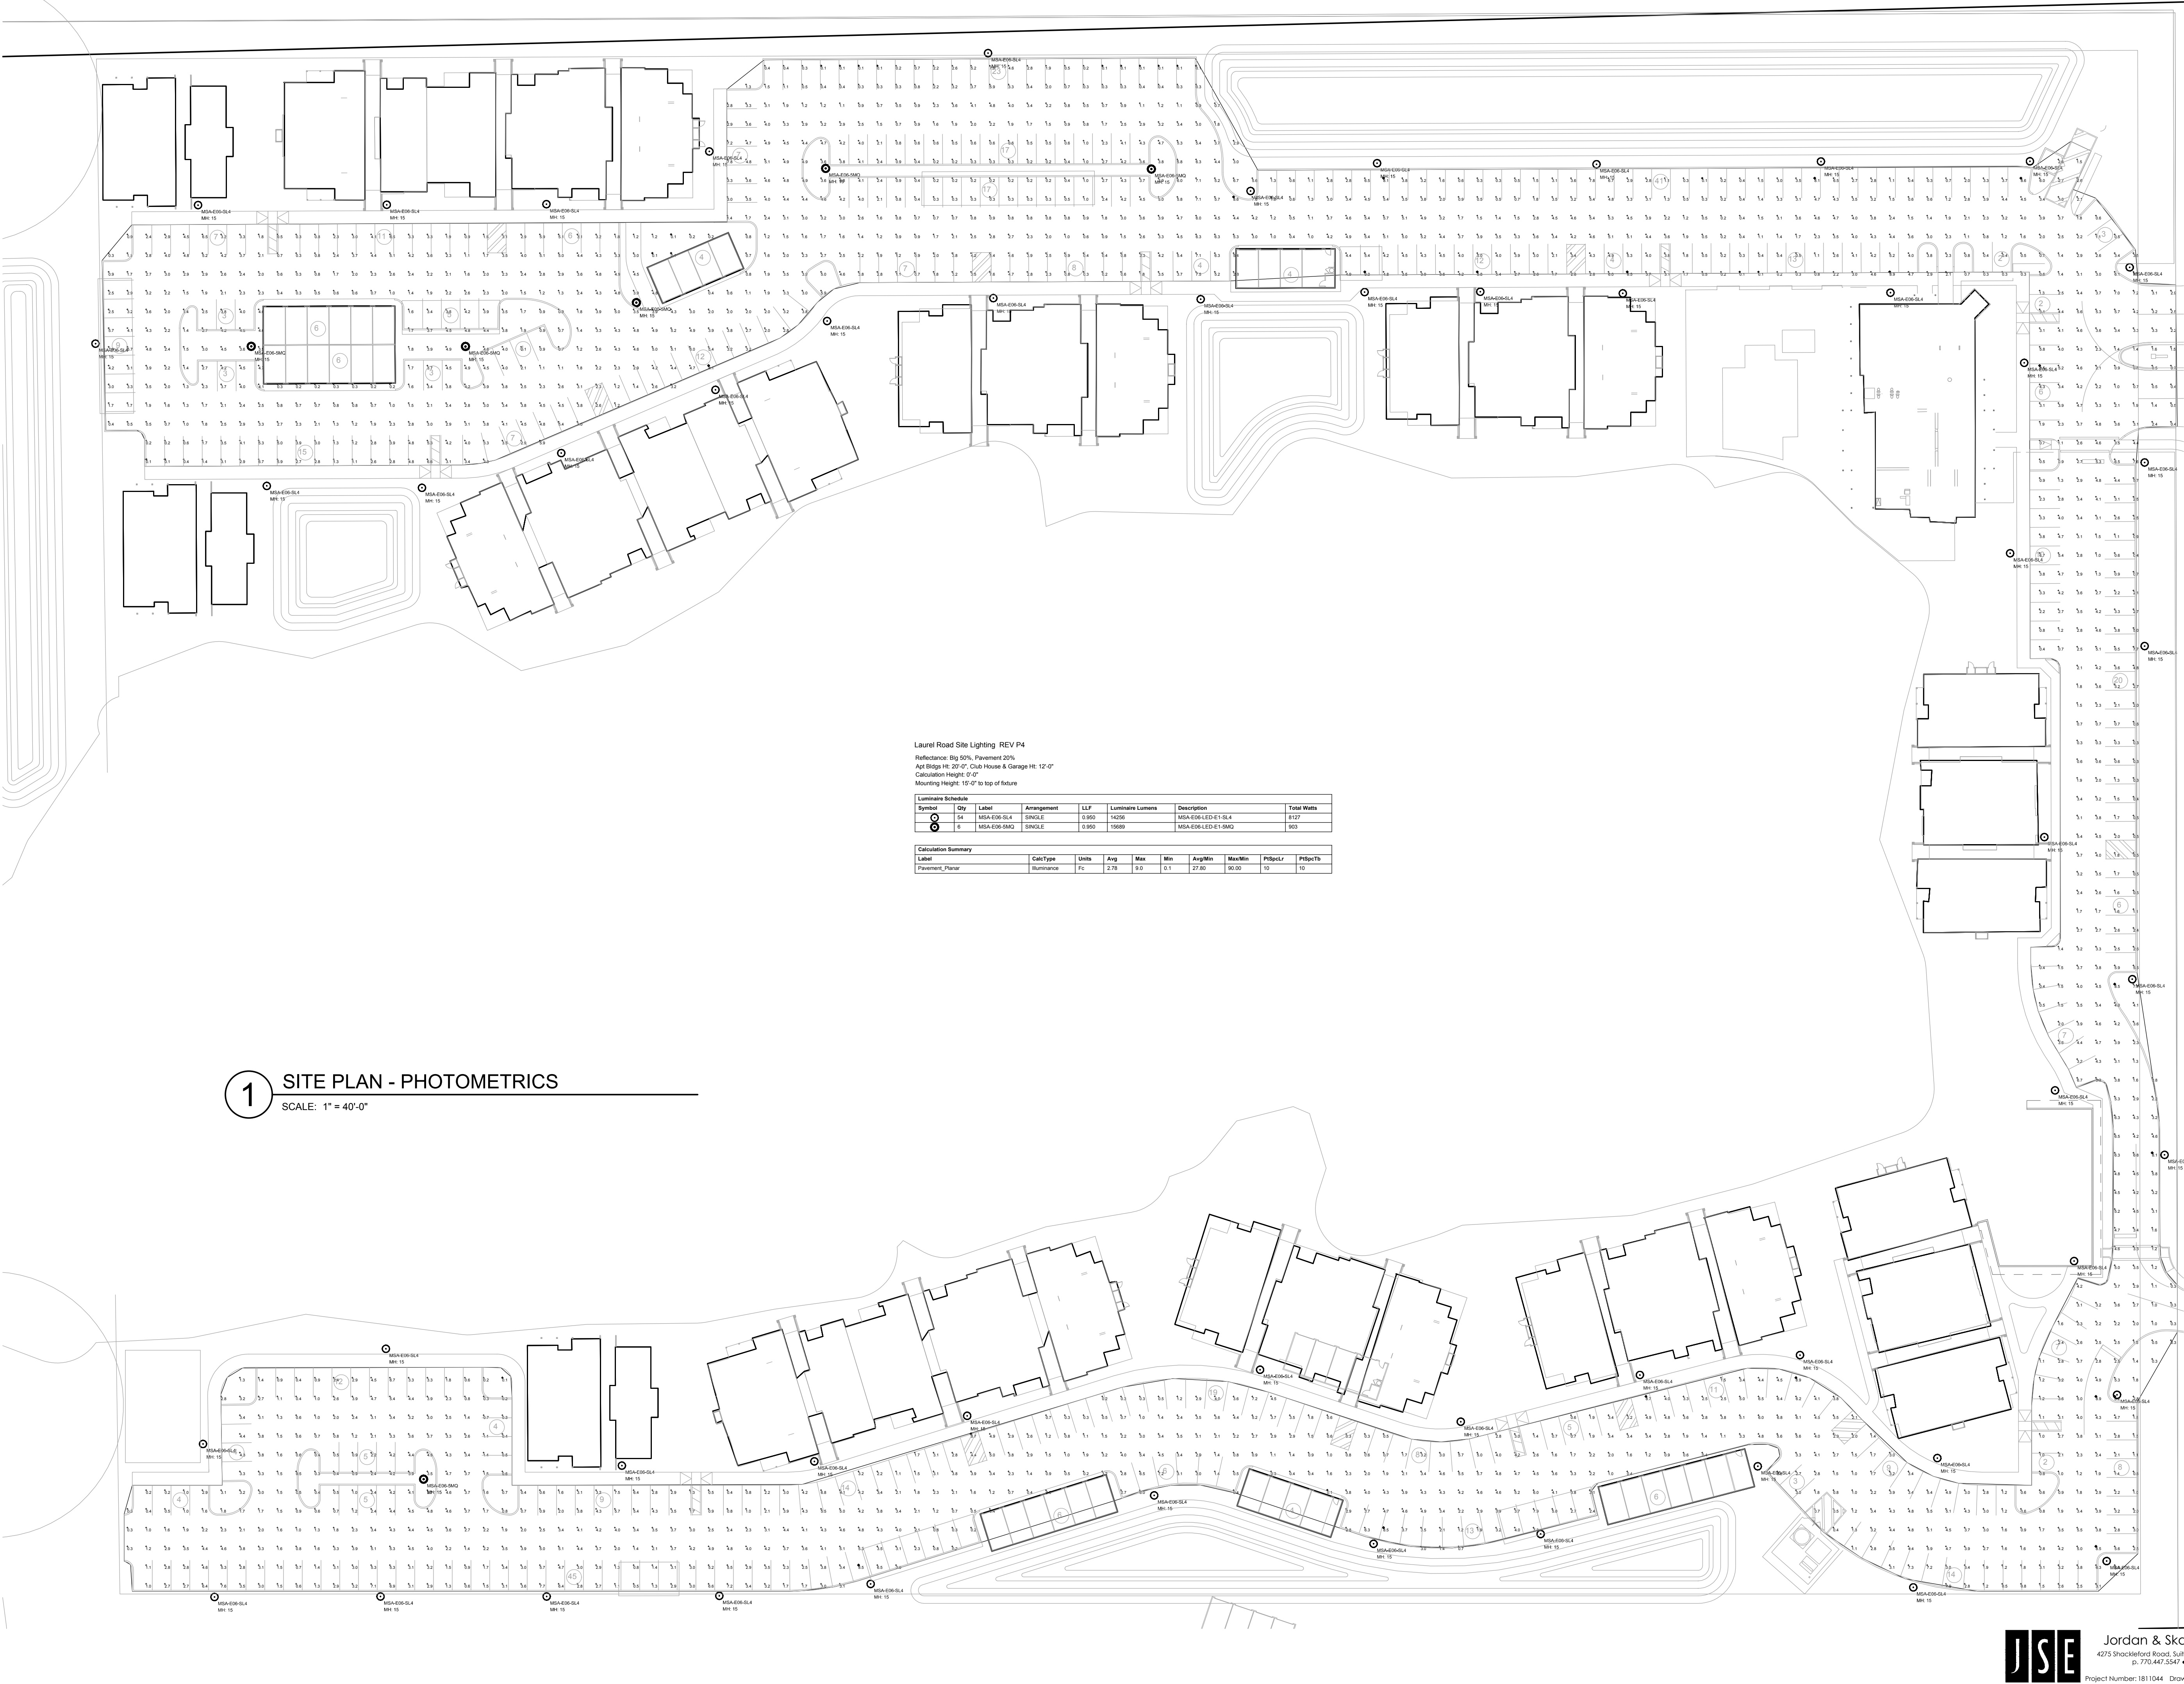

1 SITE PLAN - PHOTOMETRICS
SCALE: 1" = 40'-0"

Laurel Road Site Lighting REV P4
Reflectance: Bldg 50%, Pavement 20%
Apt Bldgs Ht: 20'-0", Club House & Garage Ht: 12'-0"
Calculation Height: 0'-0"
Mounting Height: 15'-0" to top of fixture

Luminaire Schedule						
Symbol	Qty	Label	Arrangement	LLF	Luminaire Lumens	Description
1	54	MSA-E06-SL4	SINGLE	0.900	14026	MSA-E06-LED-E1-SL4
2	5	MSA-E06-SN2	SINGLE	0.950	15689	MSA-E06-LED-E1-SN2

Calculation Summary									
Label	CalcType	Units	Avg	Max	Min	Avg/Min	Max/Min	PtBc/Lr	PtBc/Tb
Pavement_Planar	Illuminance	Fc	2.78	9.0	0.1	27.80	90.00	10	10



Jordan & Skala Engineers
4275 Shockford Road, Suite 200 • Norcross, GA 30093
p. 770.447.5547 • f. 770.446.0262

Project Number: 1811044 Drawn By: JMS Checked By: BJS

Drawn By: _____
Checked By: _____
Date Plotted: _____
Issue Dates: _____

Issue for Pricing / Bidding:

Issue for Permit Application:

Issue for Construction:

Revisions:

#	DATE	COMMENTS
1		
2		
3		
100		

©2019 by Humphreys & Partners
Architects LP All Rights Reserved
The architectural works depicted herein are the sole property of Humphreys & Partners Architects, L.P., and may not be constructed or used without its express written permission. No permission to modify or reproduce any of the architectural works, including without limitation the construction of any building, is expressed or should be implied from delivery of preliminary drawings or unsealed construction drawings. Permission to construct the building depicted in sealed construction drawings is expressly conditioned on the full and timely payment of all fees otherwise due Humphreys & Partners Architects, L.P., and, in the absence of any written agreement to the contrary, is limited to a one-time use on the site indicated on these plans.

LAUREL ROAD
APARTMENTS
VENICE, FLORIDA
VENTURES DEVELOPMENT GROUP

HUMPHREYS & PARTNERS
ARCHITECTS / FLORIDA LLC
541 EAST HORATIO AVE - STE 100 MATLAND, FL 32751
(407) 339 9323 • (407) 339 8266 FAX

DALLAS - ORLANDO - NEWPORT - NEW ORLEANS - CHICAGO -
NEW YORK - LOS ANGELES - SAN FRANCISCO -
TORONTO - CHENNAI - DUBAI - HANOI - MONTEVIDEO
CERTIFICATE #A4 0003227



SHEET CONTENTS:
SITE PLAN
PHOTOMETRICS
SHEET NO.

E-0.02

2018225

60% CONSTRUCTION DOC/HUD REVIEW 2019-04-05